 
 
 
 
 
 
 

 
 
 
 
 

 

 
 
 

 


 

 
 
 

 
 
 


 
 


LIGHTING FIXTURE SCHEDULE

PROVIDED FOR INFORMATION ONLY.
VERIFY AND INSTALL PER ELECTRICAL DRAWING

 
 
 

 
 
 
 
 
 
 
 

 
 
 
03-04-22

ITEM	SYMBOL	DESCRIPTION	QTY.	MFR. & CAT. NO.	REMARK
INTERIOR LIGHTING ITEM					
		T-BAR CEILING RECESSED MOUNTED LED LIGHTING FIXTURE, 2' X 4', 120V BAKED-ON WHITE ENAMEL FINISH.	REFER TO ELECTRICAL SHEET E-001 FOR LIGHTING FIXTURE QUANTITY	ELITE FIXTURE: 24-FPL-BL-LED-3000L/4000L/5000L-DIM10-MVOLT-35K/40K/50K-85	KITCHEN CEILING LIGHTS, FURNISHED BY OWNER INSTALLED BY GC
		T-BAR CEILING RECESSED MOUNTED LED LIGHTING EMERGENCY FIXTURE, 2' X 4', 120V BAKED-ON WHITE ENAMEL FINISH.		ELITE FIXTURE: 22-FPL-BL-LED-2000L/3000L/4000L-DIM10-MVOLT-35K/40K/50K-85	KITCHEN CEILING LIGHTS, FURNISHED BY OWNER INSTALLED BY GC
		T-BAR CEILING RECESSED MOUNTED LED LIGHTING FIXTURE, 1' X 4', 120V BAKED-ON WHITE ENAMEL FINISH.		ELITE FIXTURE: 14-FPL-BL-LED-2000L/3000L/4000L-DIM10-MVOLT-35K/40K/50K-85	KITCHEN CEILING LIGHTS, FURNISHED BY OWNER INSTALLED BY GC
		T-BAR CEILING RECESSED MOUNTED LED LIGHTING EMERGENCY FIXTURE, 2' X 4', 120V BAKED-ON WHITE ENAMEL FINISH.		ELITE FIXTURE: 24-FPL-BL-LED-3000L/4000L/5000L-DIM10-MVOLT-35K/40K/50K-85-INTGO-O-EMG-LED-10W	EMERGENCY KITCHEN CEILING LIGHTS FURNISHED BY OWNER INSTALLED BY GC
		UNIVERSAL MOUNT EXIT SIGN, LED LIGHTED, 120/277V WITH BATTERY PACK, 2 FACE, GREEN LETTER		EXITRONIX GVEX-U-BP-WB-BL-R6	EXIT SIGN FURNISHED BY OWNER, INSTALLED BY GC
		HOOD LIGHT		FURNISHED & INSTALLED BY EQUIPMENT SUPPLIER	LIGHTS SUPPLIED & PRE-WIRED BY HOOD VENDOR. ELECTRIC CONTRACTOR TO CONNECT MAIN WIRES TO SHUNT TRIP BREAKER AND HOOD CONTROL PANEL
		WALK-IN COOLER FLUORESCENT LIGHT, 120 V 48"		KASON FIXTURE: # 11810LCT400	FURNISHED BY WIC VENDOR, G.R.E. , INSTALLED BY GC
		DOWN LIGHT, RECESSED IN CEILING		ELITE HOUSING: LD6IC-AT ELITE TRIM: RL631-950L-DIMTR-120-30K-90-RL631-RT-W-WH	FURNISHED BY OWNER, INSTALLED BY GC
		DOWN LIGHT, RECESSED IN CEILING "B" SHALL DESIGNATE BLACK TRIM		ELITE HOUSING: LD6IC-AT ELITE TRIM: RL631-950L-DIMTR-120-30K-90-RL631-RT-MB-BK	FURNISHED BY OWNER, INSTALLED BY GC
		EMERGENCY DOWN LIGHT, RECESSED IN CEILING		ELITE HOUSING: LD6IC-AT ELITE TRIM: RL631-950L-DIMTR-120-30K-90-RL631-RT-W-WH	EMERGENCY RECESSED DOWN LIGHT - NORMALLY ON INVERTER UNIT - ISOLITE, IMI-12LC-V1 FURNISHED BY OWNER INSTALLED BY GC
		4" ADJUSTABLE MR16 DOWN LIGHT, RECESSED IN CEILING "W" SHALL DESIGNATE WHITE TRIM		ELITE HOUSING: BL4-50-M-120-AT-W ELITE TRIM: B1406-WH	FURNISHED BY OWNER, INSTALLED BY GC
		4" ADJUSTABLE MR16 DOWN LIGHT, RECESSED IN CEILING "B" SHALL DESIGNATE BLACK TRIM		ELITE HOUSING: BL4-50-M-120-AT-W ELITE TRIM: B1406-BK	FURNISHED BY OWNER, INSTALLED BY GC
		WHITE LED AT DINING ROOM CANOPY		ZLED FIXTURE: VIL-SIGN-60W-WHT-DC-66MOD-STRING-KIT	FURNISHED BY OWNER, INSTALLED BY GC
		WHITE LED AT FIXTURE LOW WALL		NOVA FLEX - PRO SERIES FIXTURE: BENDABLE 3916	FURNISHED BY OWNER, INSTALLED BY GC
		BRONZE SWOOP LIGHT		FIXTURE - TBD	DINING AREA - FURNISHED BY OWNER, INSTALLED BY GC
		12" DIA. PENDANT		KAI PENDANT 2 BULB: LED EDISON LAMP:1173467	FURNISHED BY OWNER, INSTALLED BY GC
		MICRO INVERTER		EVENLITE #PWII12LC	FURNISHED BY OWNER, INSTALLED BY GC
		SPEAKER		-	FURNISHED BY MUSIC VENDOR, INSTALLED BY MUSIC VENDOR

NIGHT LIGHTING REQUIREMENTS: "NL" DESIGNATION INDICATED NIGHT LIGHT ON UNSWITCHED CIRCUIT.

 
 

- ONE NL BY SERVICE COUNTER, POS / CASHIER
- ONE NL BY POS / CASHIER AT DRIVE THRU STATION IF APPLICABLE
- ONE NL BY EACH EXIT DOORS IN DINNING ROOM & BACK OF HOUSE

EXTERIOR LIGHTING

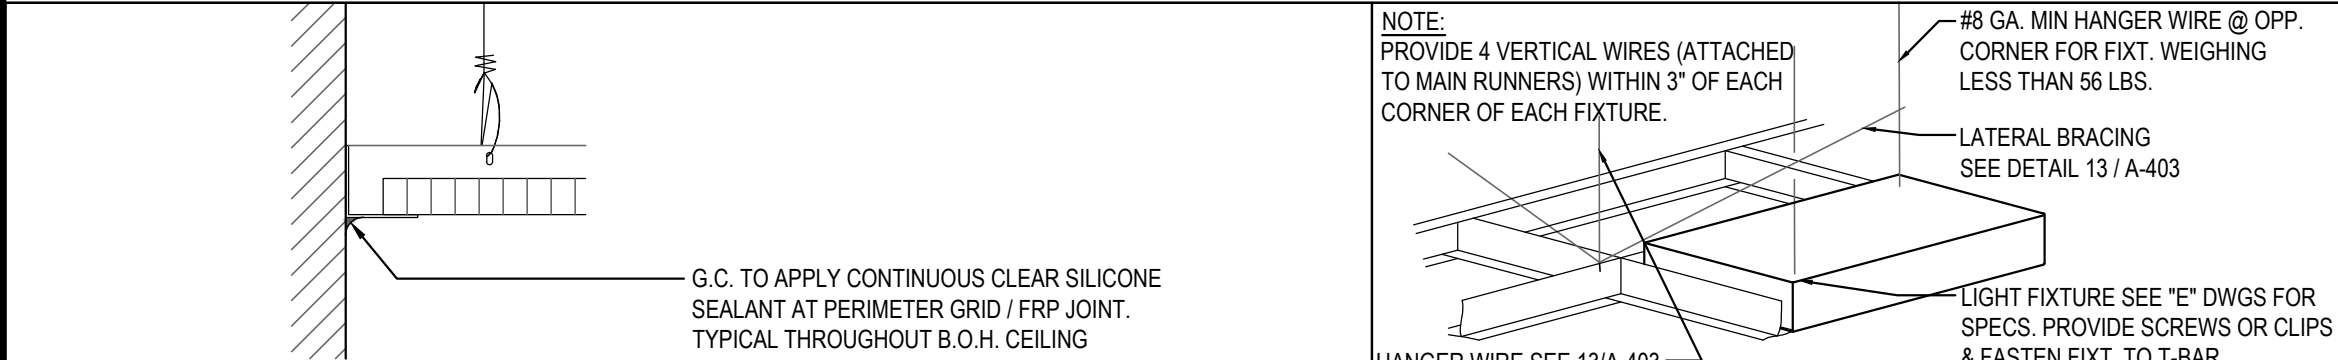
		LINEAR LIGHT AT EXTERIOR STORAGE ROOM	REFER TO ELECTRICAL SHEET E-001 FOR LIGHTING FIXTURE QUANTITY	COOPER MX-4VT2-LD4-6-DR-UNV-L840-CD1-WL-U	FURNISHED BY OWNER, INSTALLED BY GC
		WALL MOUNTED OVER SERVICE DOOR FIXTURE		ORACLE: OWP-FC-116-LED-3500L-DIM10-MVOLT-50K-BK	OVER EXTERIOR SERVICE DOOR. REFER ELEVATIONS FOR HEIGHT FURNISHED BY OWNER, INSTALLED BY GC
		NAVILITE EMERGENCY LIGHT		EXITRONIX MLED1-G-WP	OVER EXTERIOR ENTRANCE & SERVICE DOORS. REFER ELEVATIONS FOR HEIGHT. FURNISHED BY OWNER, INSTALLED BY GC
		EXTERIOR RECESS EMERGENCY LIGHT		ELITE HOUSING: LD6IC-AT LED MODULE: ELITE LED LIGHTING WET LOCATION: RL607-14W-120-FL-30K-SN-SN-S-WET LOCATION	EMERGENCY RECESSED DOWN LIGHT - NORMALLY ON INVERTER UNIT - ISOLITE, IMI-12LC-V1 FURNISHED BY OWNER INSTALLED BY GC
		DECORATIVE LED WALL SCONCE		HINKLEY LIGHTING, ATLANTIS, BLACK, 1649SK-LED	AT ENTRY DOORS. REFER ELEVATIONS FOR HEIGHT FURNISHED BY OWNER, INSTALLED BY GC
		DECORATIVE LED WALL SCONCE		HINKLEY LIGHTING, SILO, BRONZE, 13594AZ-LL, LED	ALONG REAR EIFS BAND FURNISHED BY OWNER, INSTALLED BY GC
		WALL MOUNTED OVER SERVICE DOOR FIXTURE		LITHONIA LIGHTING WPX1 LED P2 40K MVOLT DDBXD M4	OVER DRIVE THRU AREA SERVICE DOOR FURNISHED BY OWNER, INSTALLED BY GC
		LED MOTION SECURITY FLOODLIGHT		LITHONIA LIGHTING HGX LED 2RH 40K 120 MO DDB M2	INTERIOR LIGHT SENSOR TO BE WALL MOUNTED AT +142" FURNISHED BY OWNER, INSTALLED BY GC

CEILING SCHEDULE

INSTALLED AND FURNISHED BY GC UNLESS NOTED OTHERWISE

NO	MANUFACTURER	DESCRIPTION	MATERIAL	FINISH
	ARMSTRONG	2' X 2' SUSPENDED T-BAR GRID CEILING SYSTEM	OPTIMA 9/16" SQUARE TEGULAR ITEM # 3251	SUSPENSION SYSTEM: 9/16" SUPRAFINE, COLOR: BLIZZARD WHITE CONTACT: SHERRY BRUNT (1-800-442-4212)
	USG	2' X 4' SUSPENDED T-BAR GRID CEILING SYSTEM	"VINYL ROCK" VINYL CLAD GYP. BD PANELS	SMOOTH AND WASHABLE WHITE
	GOLD BOND	MONOLITHIC CEILING ON METAL FRAMING	5/8" GYP. BD.	SMOOTH PAINT - WHITE AND WASHABLE

SEE SHEET A-103 FOR PAINT SCHEDULE



CEILING GRID DETAIL

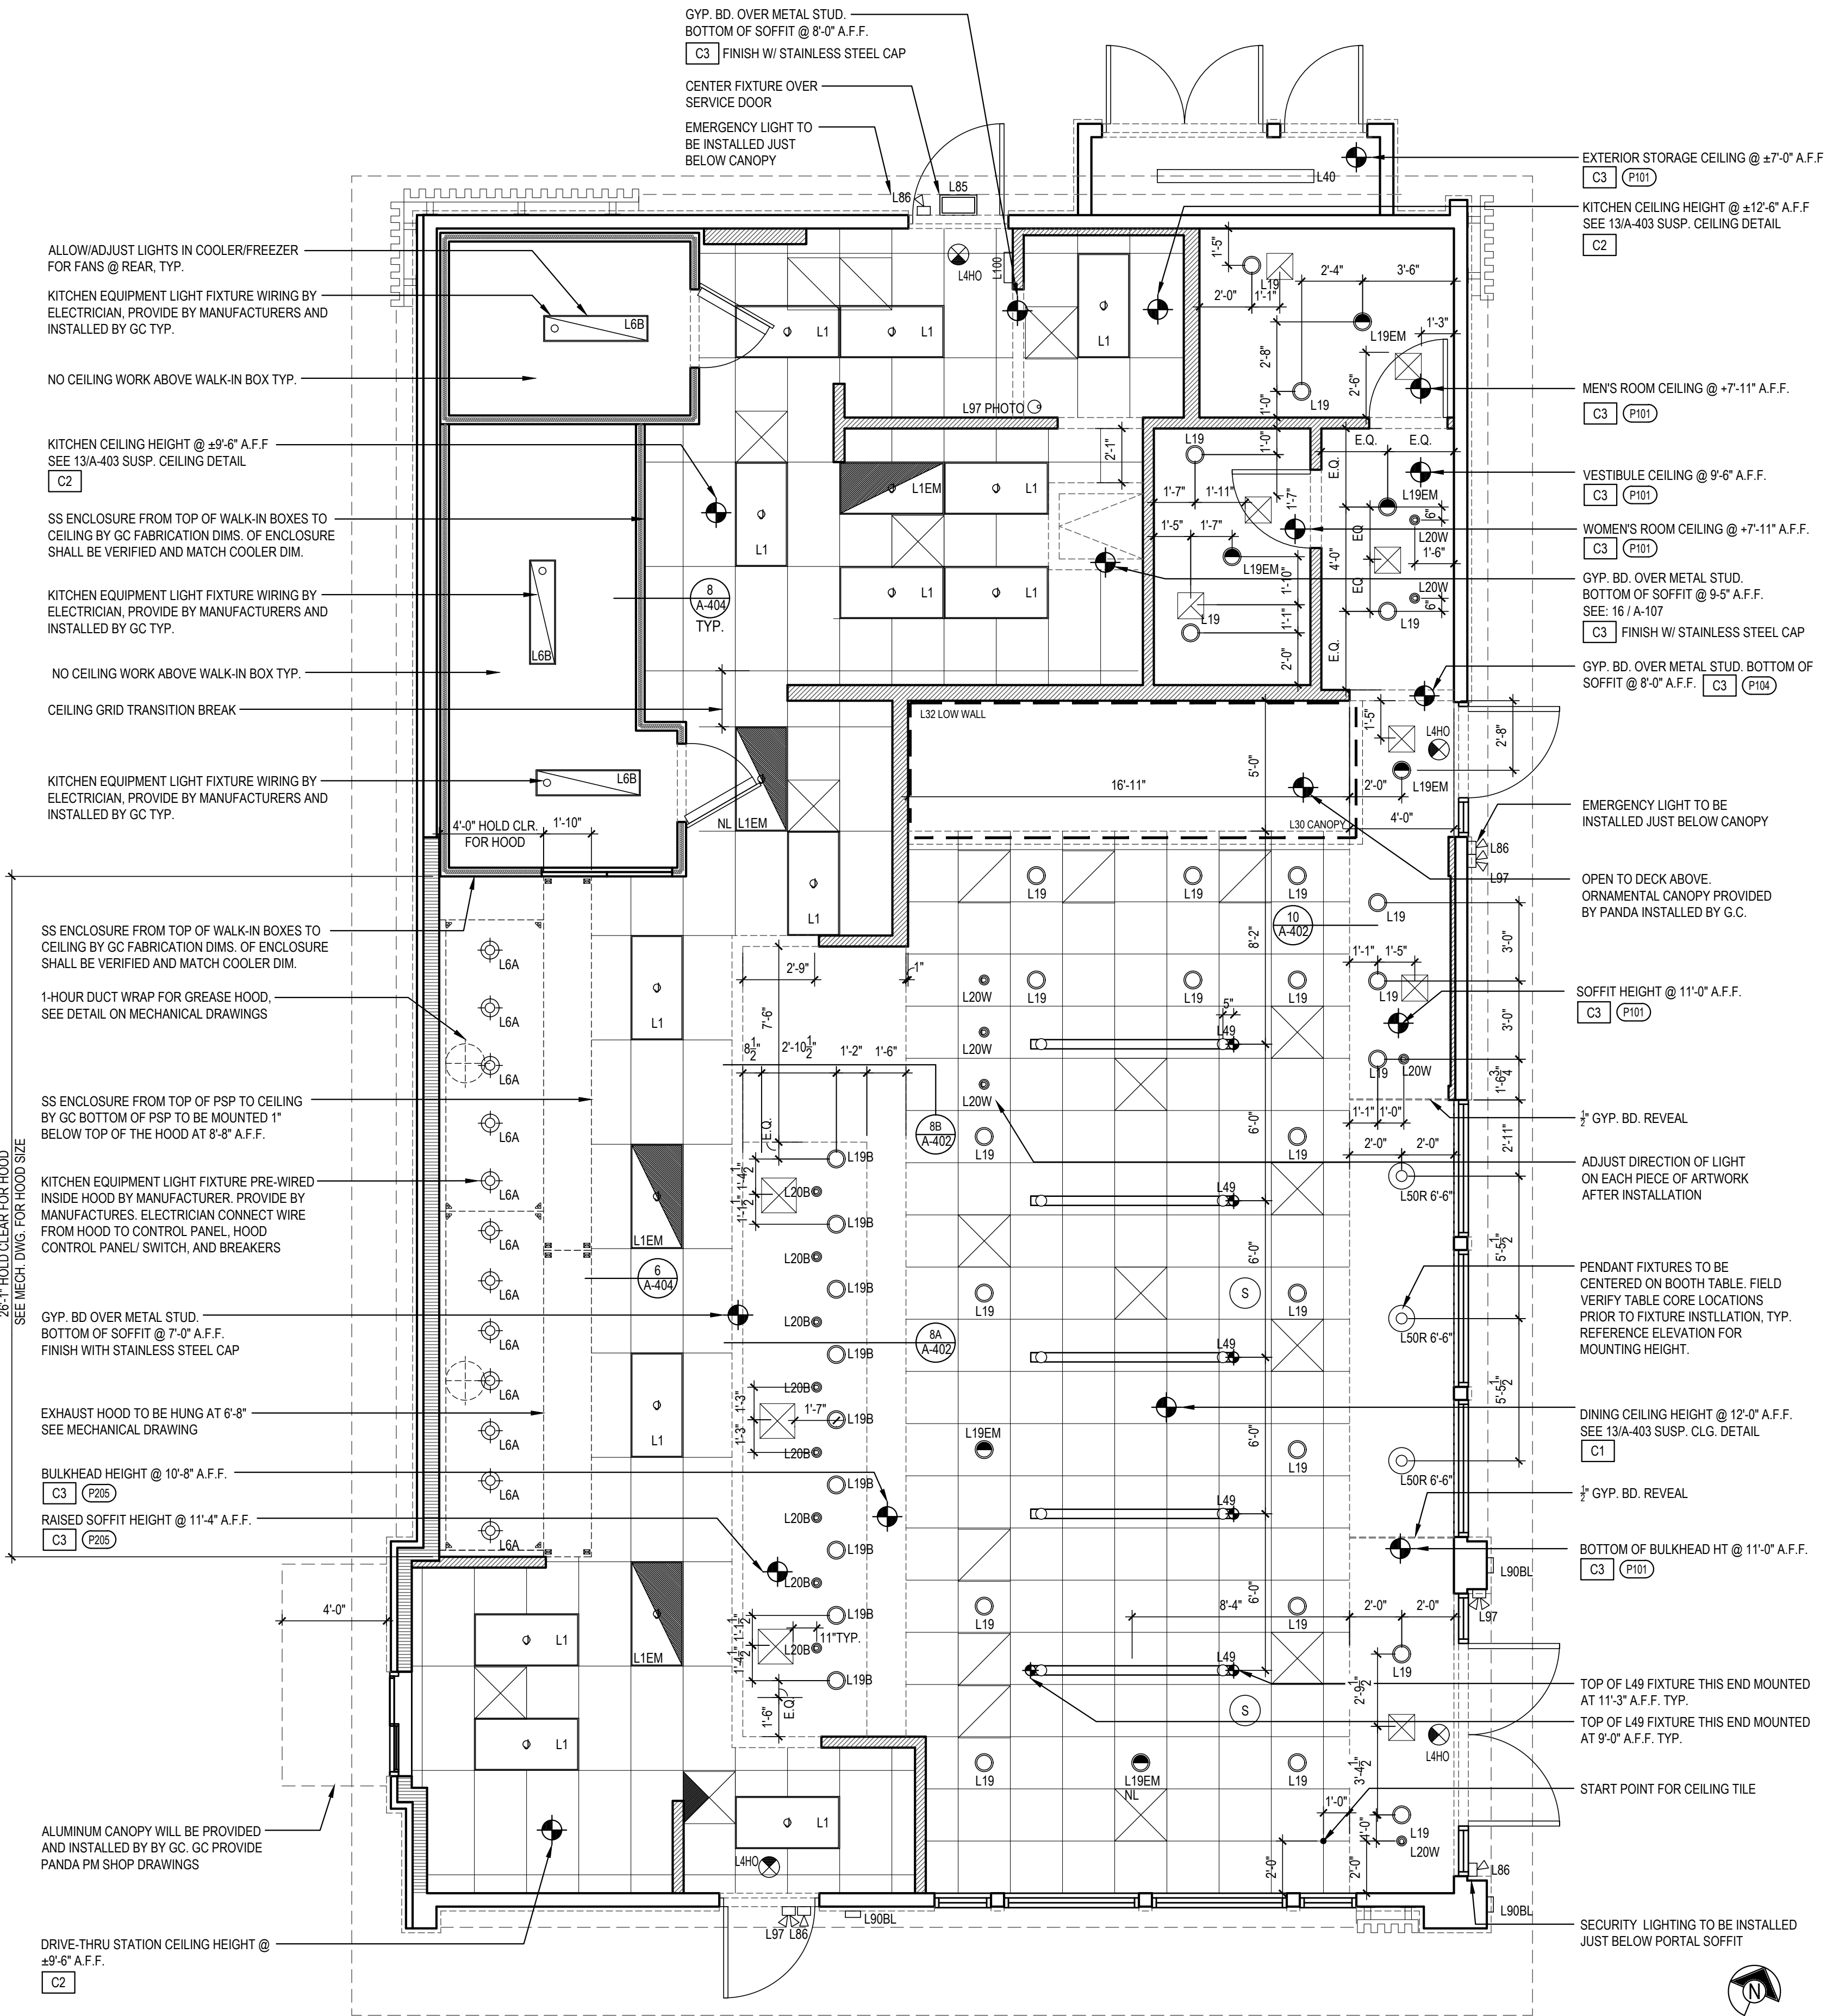
3

Scale= NTS

LIGHT FIXTURE DETAIL

2

Scale= NTS



REFLECTED CEILING PLAN

1

Scale= 1/4" = 1'-0"

A-105



PANDA EXPRESS, INC.
1683 Walnut Grove Ave.
Rosemead, California
91770

Telephone: 626.799.9898
Facsimile: 626.372.8288

All ideas, designs, arrangement and plans indicated or represented by this drawing are the property of Panda Express Inc. and were created for use on this specific project. None of these ideas, designs, arrangements or plans may be used by or disclosed to any person, firm, or corporation without the written permission of Panda Express Inc.

REVISIONS:

1	03.31.2023	ISSUE FOR PERMIT
2	05.26.2023	ISSUE FOR BID

ISSUE DATE:

1 03.31.2023 ISSUE FOR PERMIT

2 05.26.2023 ISSUE FOR BID

DRAWN BY: NS, KRT, IVG

PANDA PROJECT #: - D25303

C&P PROJECT #: - 2230054



05.26.2023



PANDA EXPRESS

PANDA HOME 2600
950 WEST WADE HAMPTON BLVD
GREER, SC 29651

A-105

REFLECTED CEILING PLAN

PANDA HOME 2600 R4